



Do not scale the drawing  
 Date : 03-02-2017  
 Rev.Date : 10-03-2017

Drawing Title : Interior Layout  
Project : Pattambi Branch

Client : United India Insurance Company Limited  
Option no : 2 Rev no : 2


Consultants :  
**M** ANASARA CONSULTANTS  
 37/3744, Sreevalsam  
 Ponoth Road, Kaloor  
 Cochin-682017, Kerala  
 Ph: +91- 484 - 2102254  
 manasaradesigns@yahoo.com

All dimensions are in cm unless specified

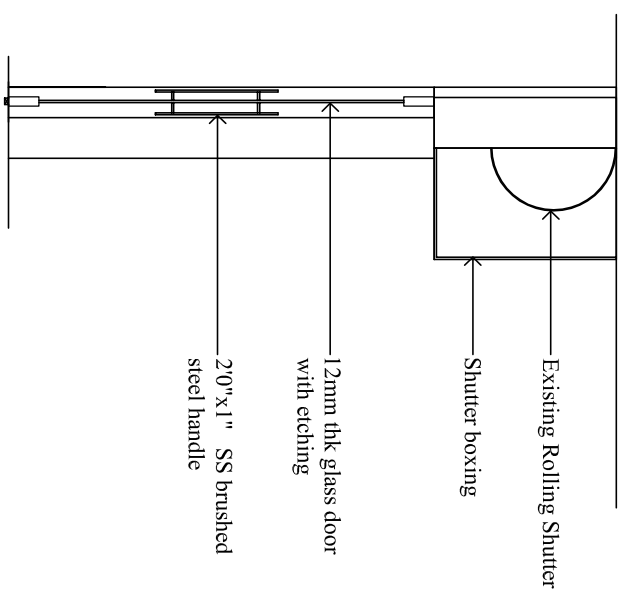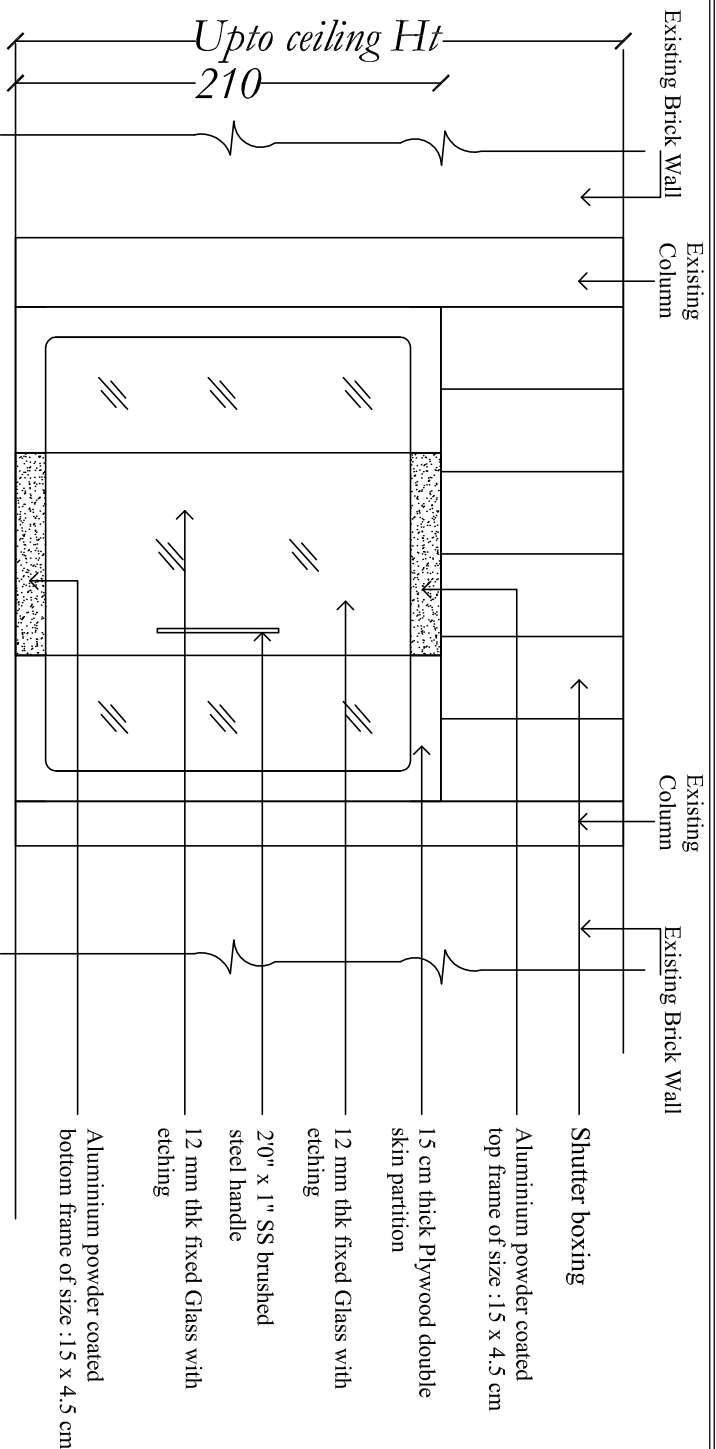


**ELEVATION**

**SECTION B-B**

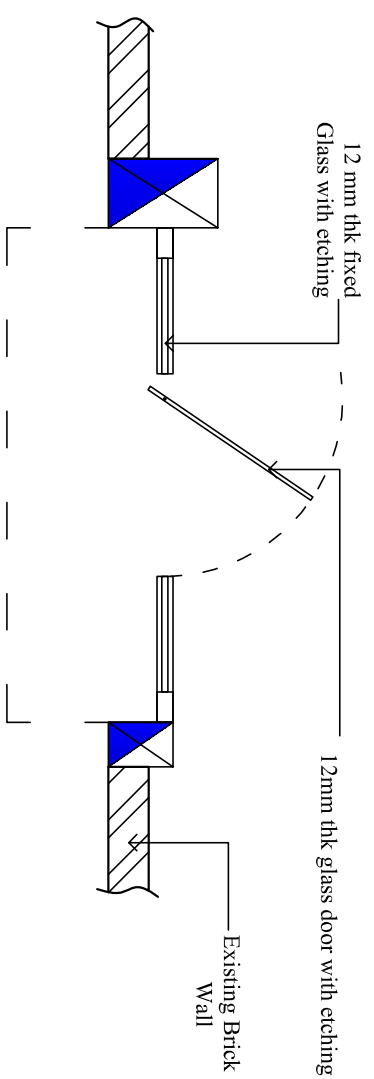

**PLAN**

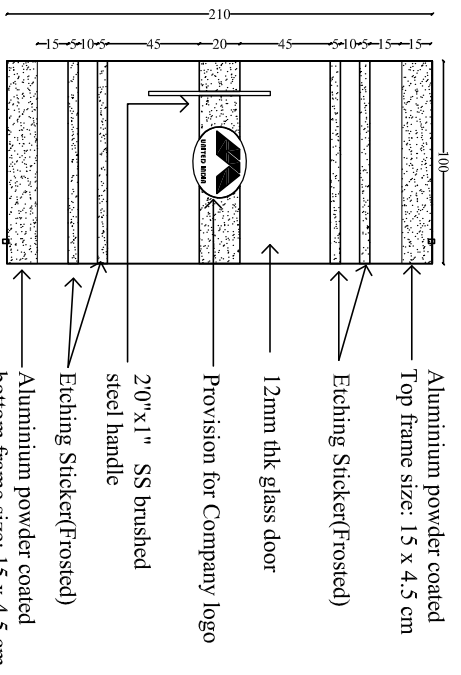

**DOOR ETCHING DETAILS**

Not to Scale

Date : 19-06-2017





Drawing : **Entrance Door**


Client : **United India Insurance Company Ltd**






Branch : **Pattambi**

Consultants : **MANASAKA CONSULTANTS**  
 37/3744, Sivakasi  
 Poonthi Road, Kallar  
 Ponnaiyandur, Kallar  
 Pattambi, Tamil Nadu  
 manasakaengineers@gmail.com

All dimensions are in cm unless specified

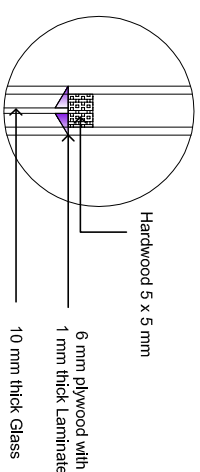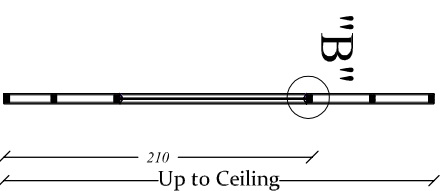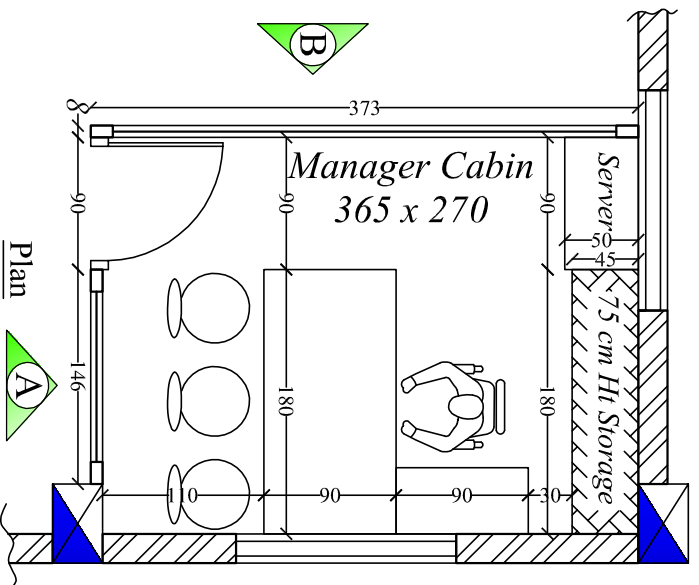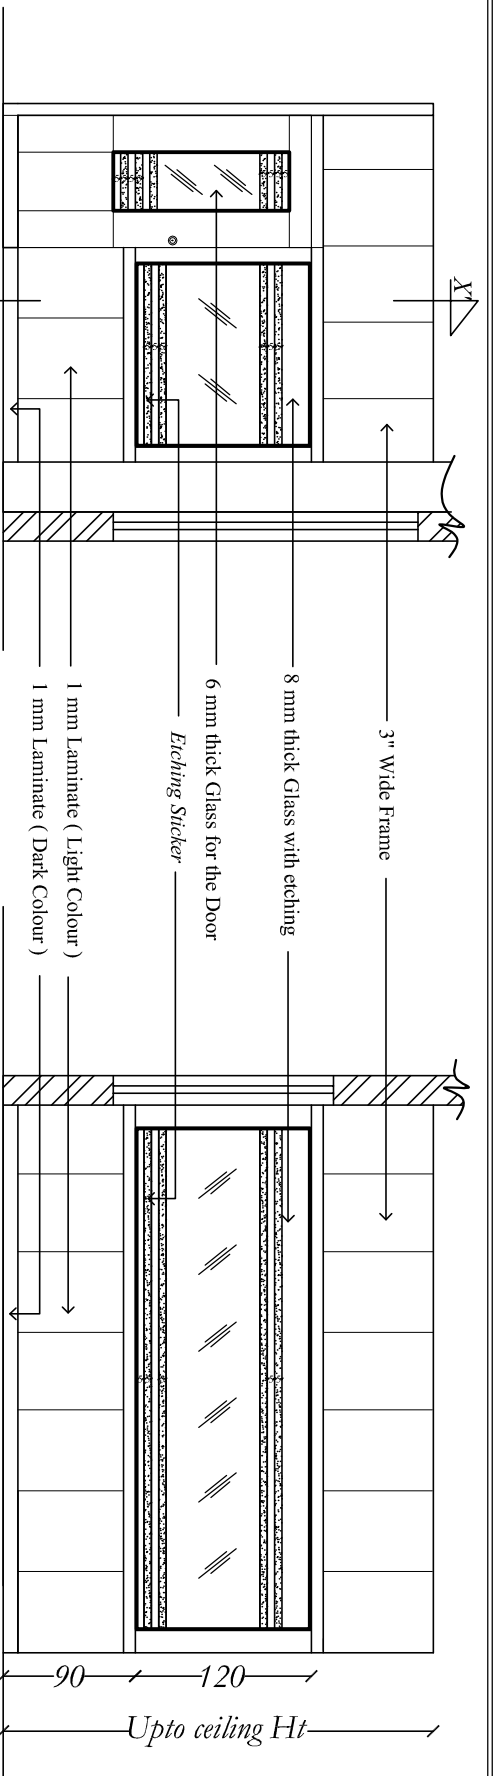

Not to Scale	Drawing	Client : <i>United India Insurance Company Ltd</i>	<b>Consultants :</b>  37/374A, Sreevidyam Pochampalli Road, Kalluru, Patnam, Hyderabad - 500042 Ph: 01-4610-7000 manasaradesigns@vsnl.com
Date : 19-06-2017	<i>Manager Cabin</i>	Branch : <i>Pattambi</i>	
All dimensions are in cm unless specified			

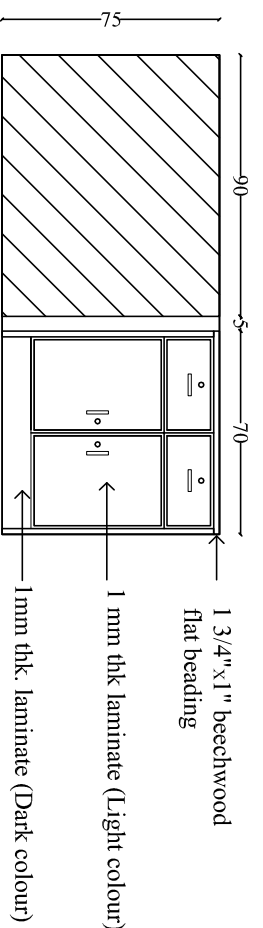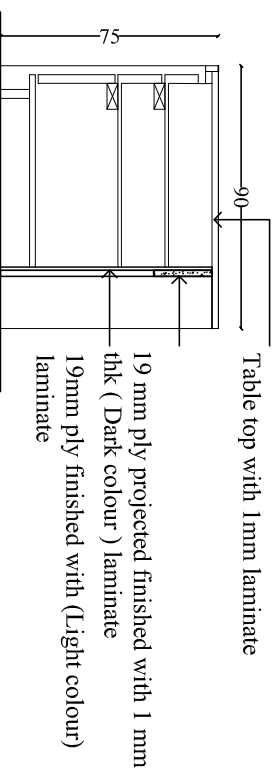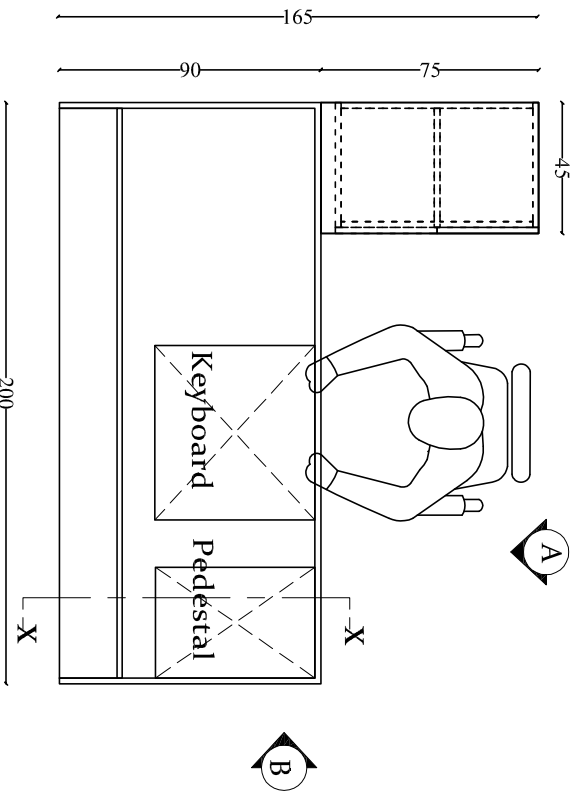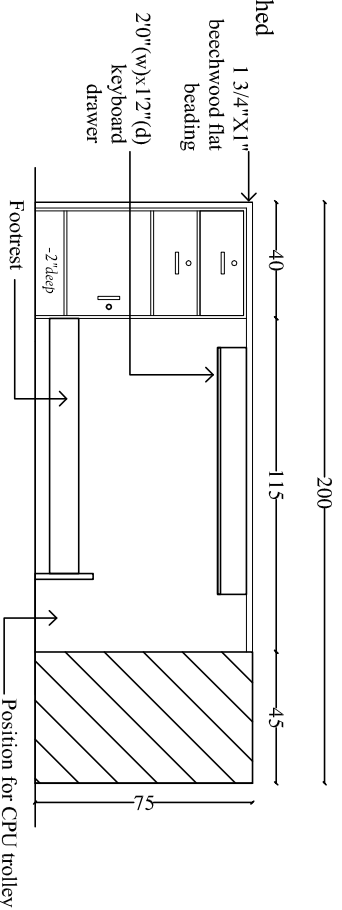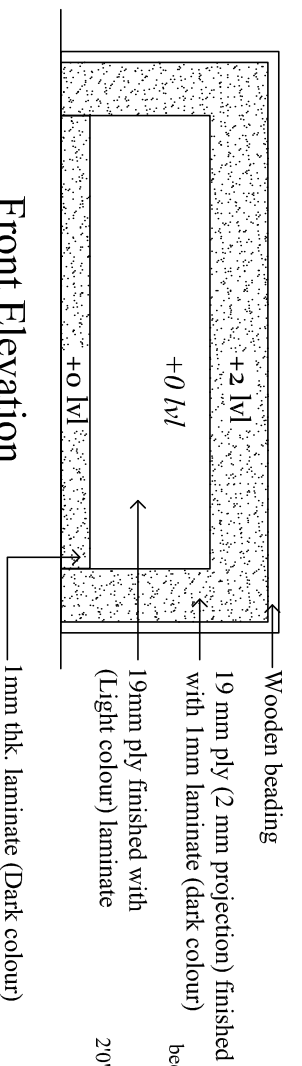

Not to Scale

Drawing : **Manager Table with side table**

Client : **United India Insurance Company Ltd**

Consultants :


Date : 19-06-2017

Branch : **Pattambi**

37/37/4, Steendham  
 Poroth Road Kallor  
 Cochin-682017 Kerala  
 Ph: +91-484 - 2102254  
 manasatradesigns@yahoo.com

**M** ANASARA CONSULTANTS

All dimensions are in cm unless specified

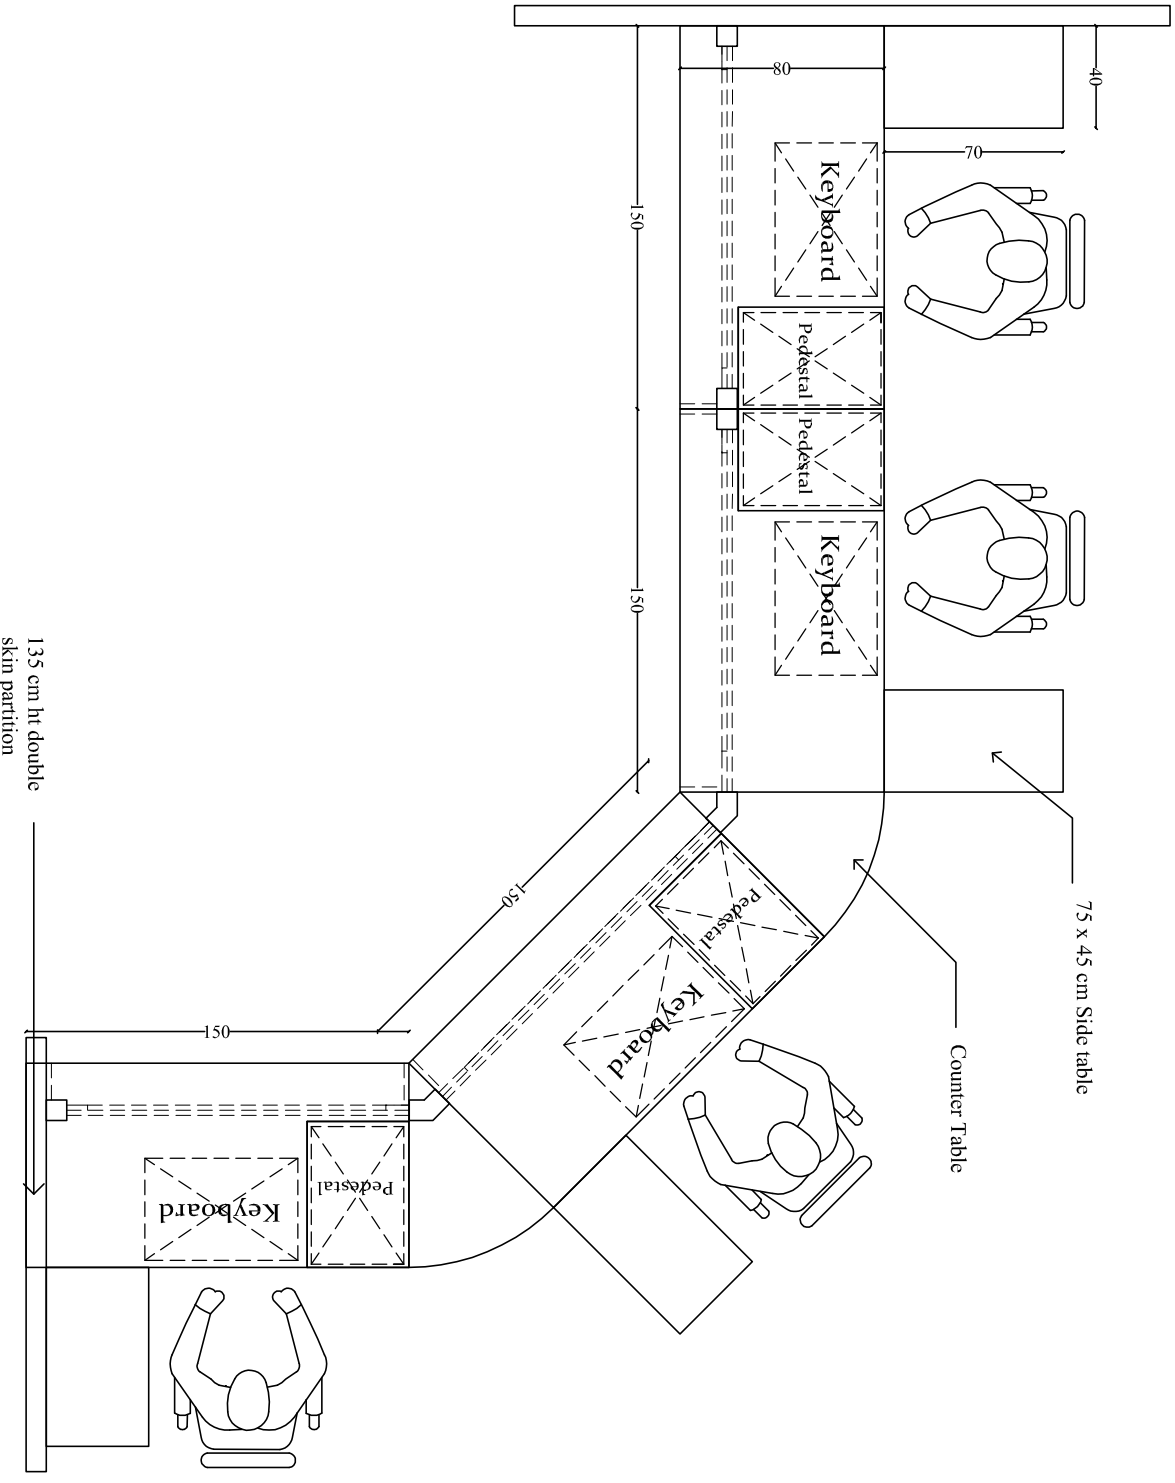

Not to Scale

Drawing :

*Running Counter Table*

Date : 19-06-2017

Client :


*United India Insurance Company Ltd*

Branch : *Pattambi*

Consultants :


**M**ANASARA CONSULTANTS  
 37/3744, Seevakkam  
 Poroth Road, Kaloor  
 Cochin-682017, Kerala  
 Ph: +91-484-2102254  
 manasaradesigns@yahoo.com

All dimensions are in cm unless specified

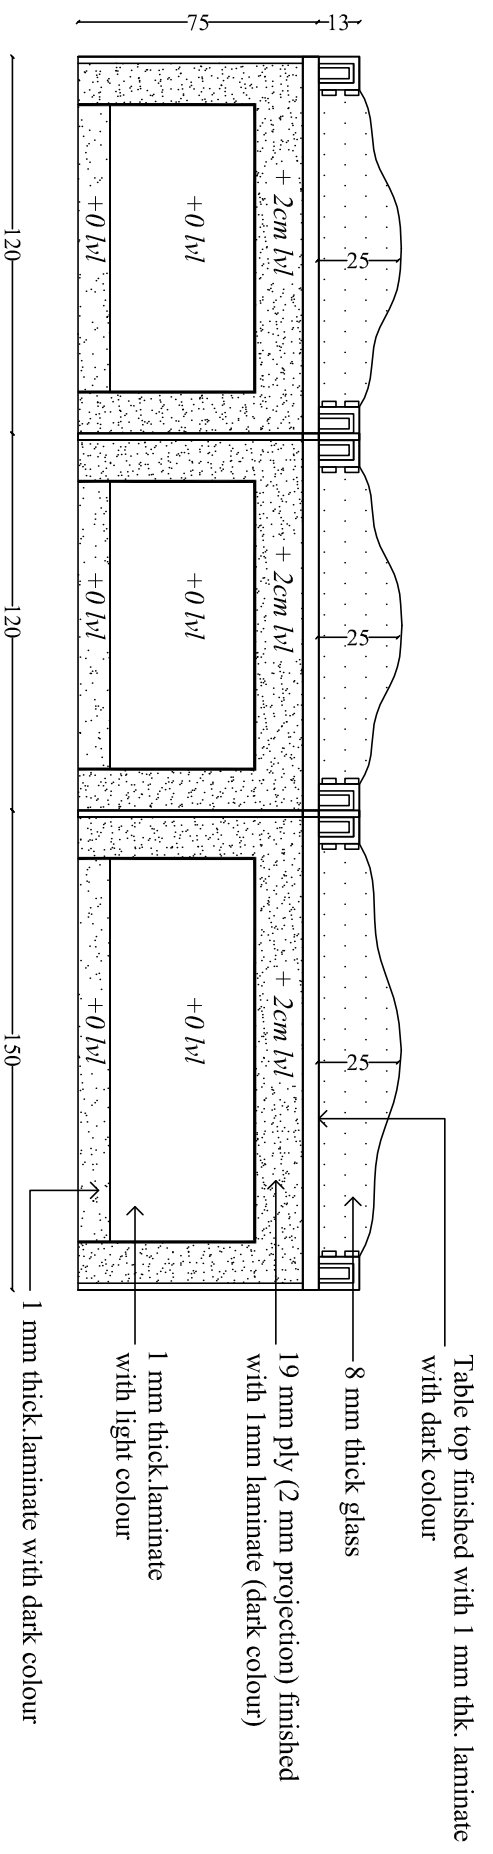


**Front Elevation**

75 x 45 cm Side table

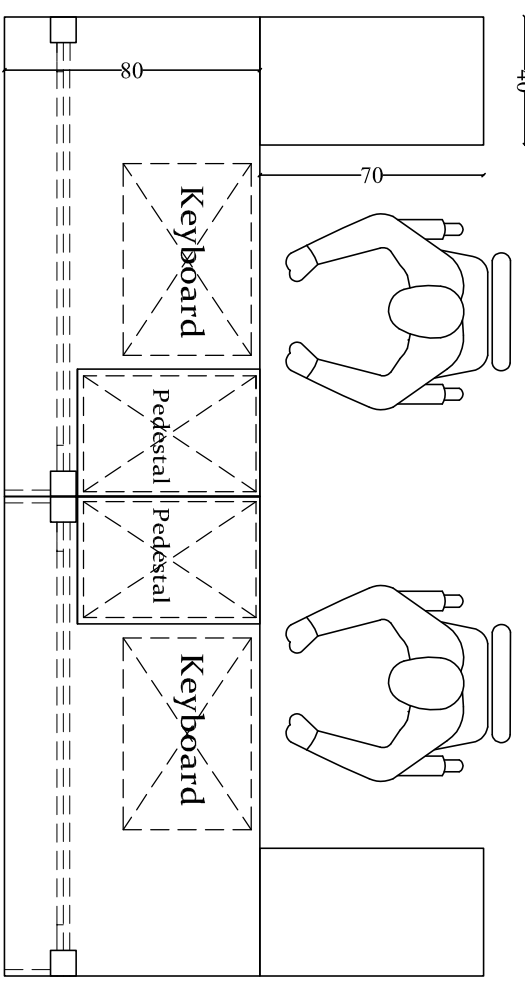

**Plan**

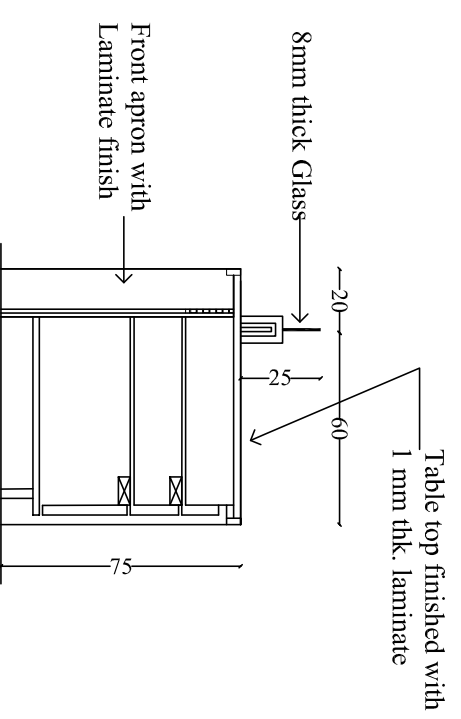

**Section XX**

Not to Scale

Drawing :

**Running Counter Table  
(Details)**

Date : 06-02-2017

Client :

**United India Insurance Company Ltd**

Branch :

**Pattambi**


Consultants :

**MANASARA CONSULTANTS**


37/3744, Sreevalsam  
Ponoth Road, Kalloor  
Cochin-682017, Kerala  
Ph: +91- 484 - 2102254  
manasaradesigns@yahoo.com

All dimensions are in cm unless specified




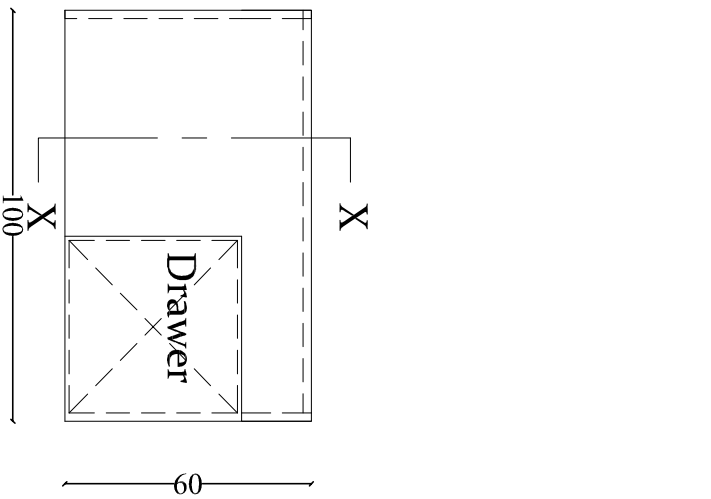

**Plan**

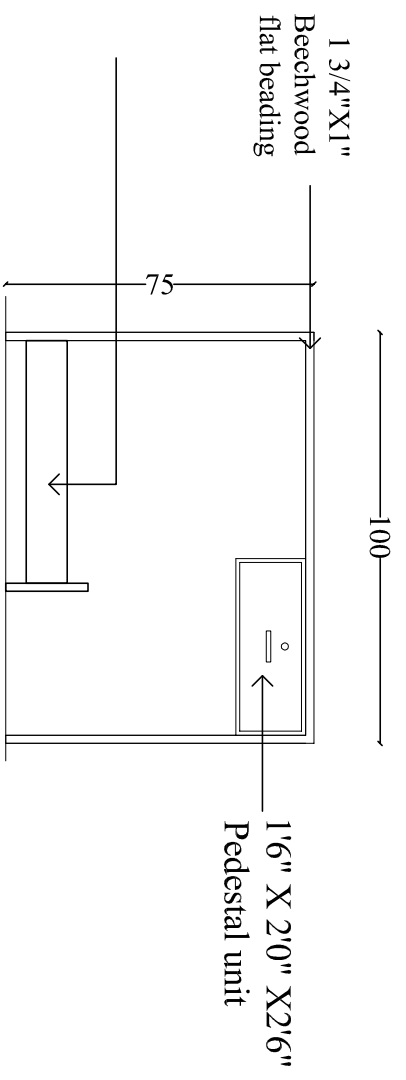

**Elevation A**

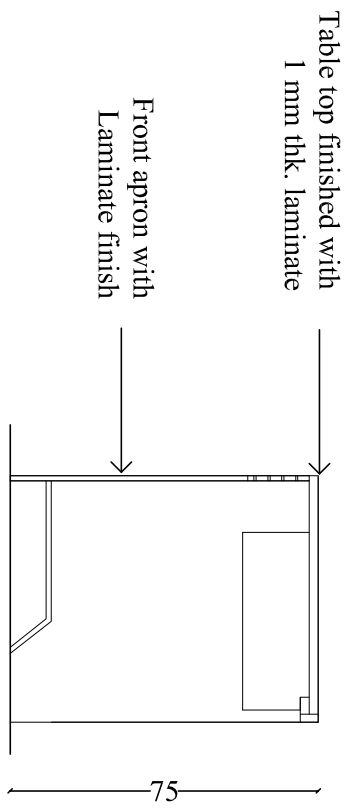

**Section XX**

Not to Scale	Drawing : <i>Table type -3</i> <i>Server Table</i>
Date : 19-06-2017	


Client : <i>United India Insurance</i> <i>Company Ltd</i>
Branch : <i>Pattambi</i>

**Consultants :**


**ANASARA CONSULTANTS**  
 37/3744, Sreevalsam  
 Poroith Road, Kallor  
 Cochin-682017, Kerala  
 Ph: +91- 484 - 2102254  
 manasaraedesigns@yahoo.com

All dimensions are in cm unless specified




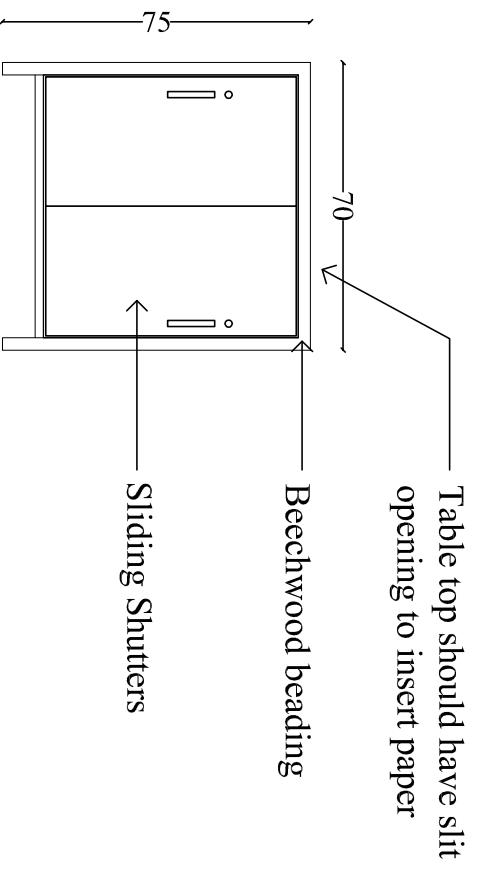


**Elevation-A**

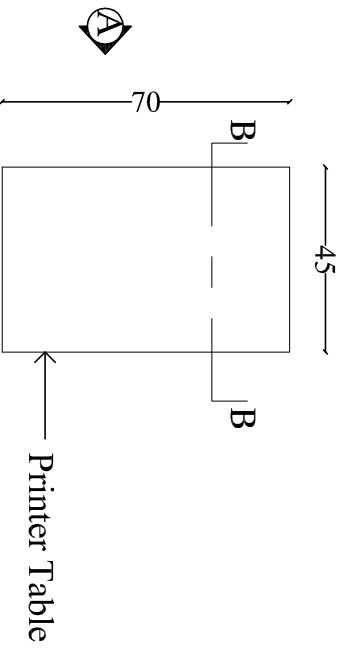


**Plan**



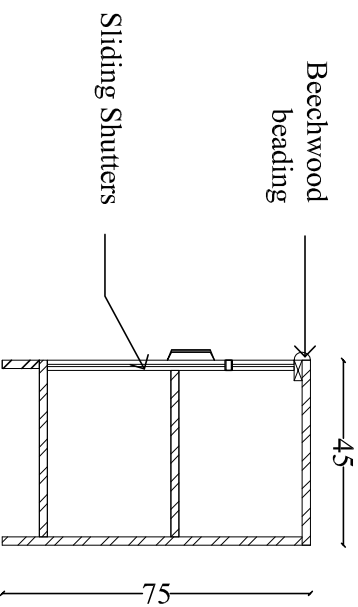


**Section BB**


<p>Not to Scale</p>	<p>Drawing : <b>Printer Table</b> (for running counter)</p>	<p>Client : <b>United India Insurance Company Ltd</b></p> <p>Branch : <b>Pattambi</b></p>	<p>Consultants :</p>  <p><b>ANASARA CONSULTANTS</b></p> <p>37/3744, Sreevalsam Ponoth Road, Kador Cochin-682017, Kerala Ph: +91- 484 - 2102254 manasaraesigns@yahoo.com</p>
<p>All dimensions are in cm unless specified</p>			

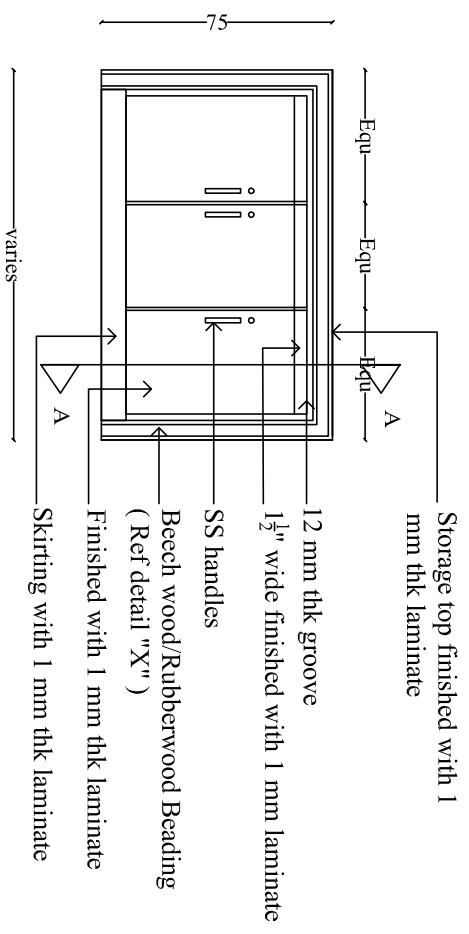



**Elevation**

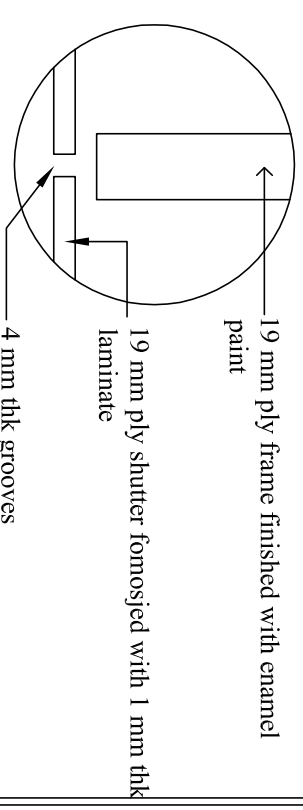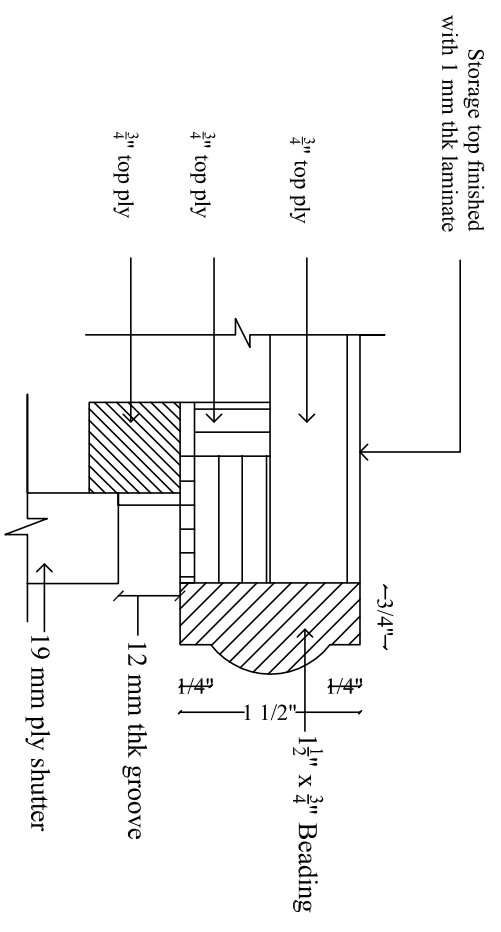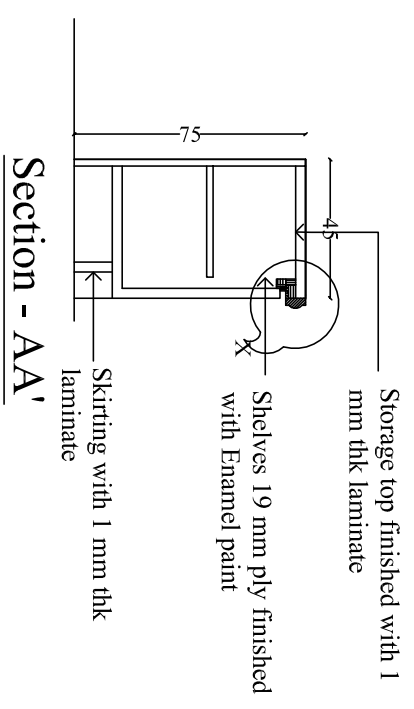

<p>Not to Scale</p>		<p>Client : <i>United India Insurance Company Ltd</i></p>	
<p>Date : 19-06-2017</p>		<p>Branch : <i>Pattambi</i></p>	
<p>Drawing : <i>Storage(75 cm Ht)</i></p>		<p>Consultants :</p>	
<p>All dimensions are in cm unless specified</p>			
<p><b>ANASARA CONSULTANTS</b>          37/374A, Sreevalsam          Ponoh Road, Kabor          Cochin-682017, Kerala          Ph. +91- 484- 2102254          manasaraesigns@yahoocom</p>			

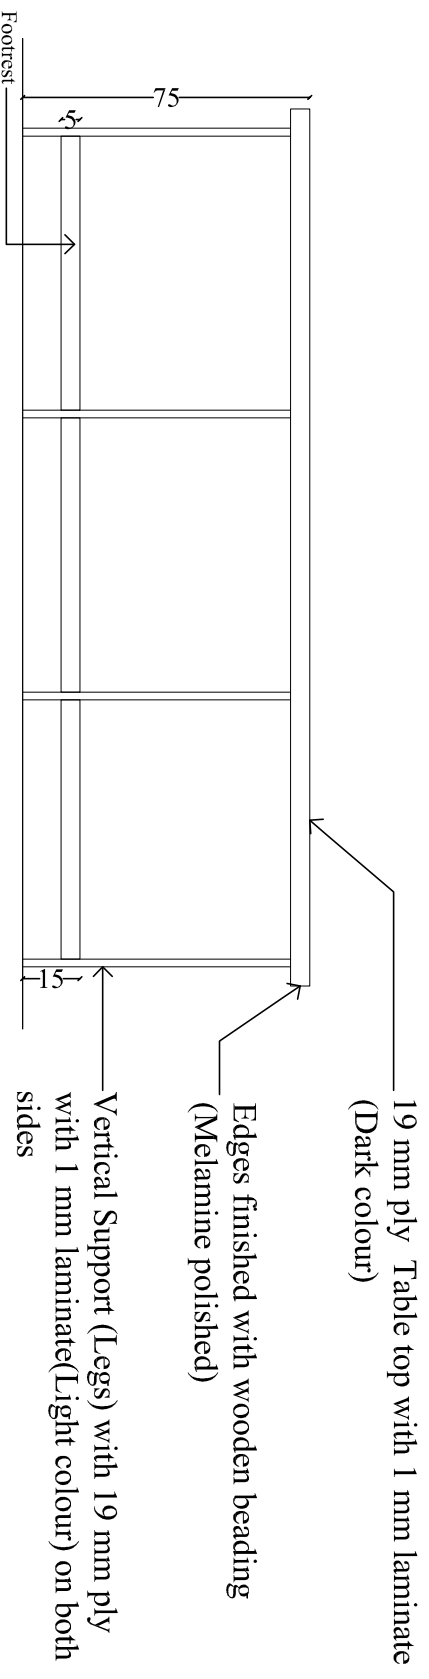

**Elevation A**

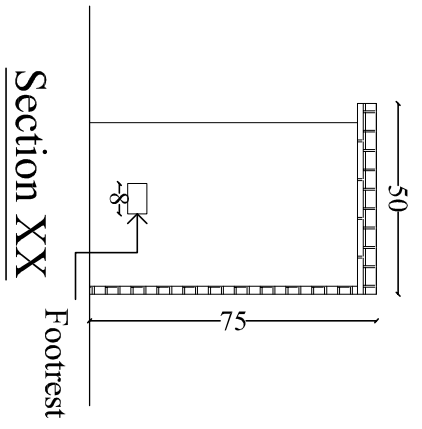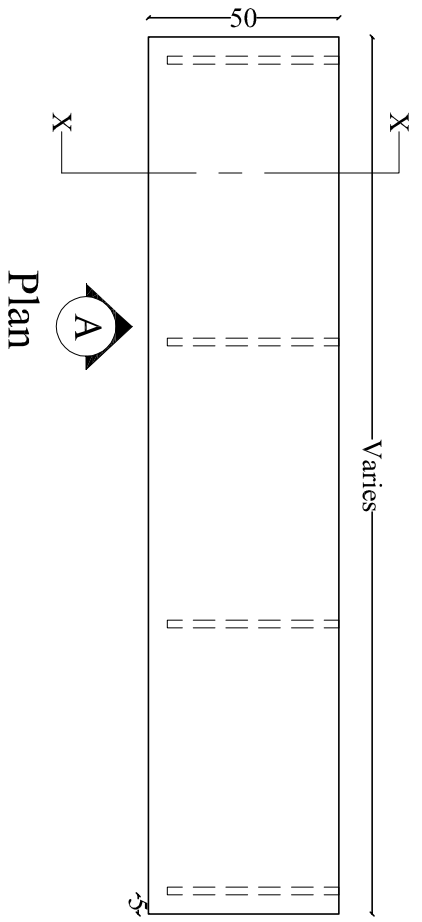

Not to Scale

Date : 19-06-2017

Drawing :

*Agents / Pantry Counter*

Client :

*United India Insurance Company Ltd*

Branch :


*Pattambi*

Consultants :


**ANASARA CONSULTANTS**

37/37/4, Sreevalsam  
Ponoth Road, Kallor  
Cochin-682017, Kerala  
Ph: +91-484-2702254  
manasara.designs@yahoo.com

All dimensions are in cm unless specified

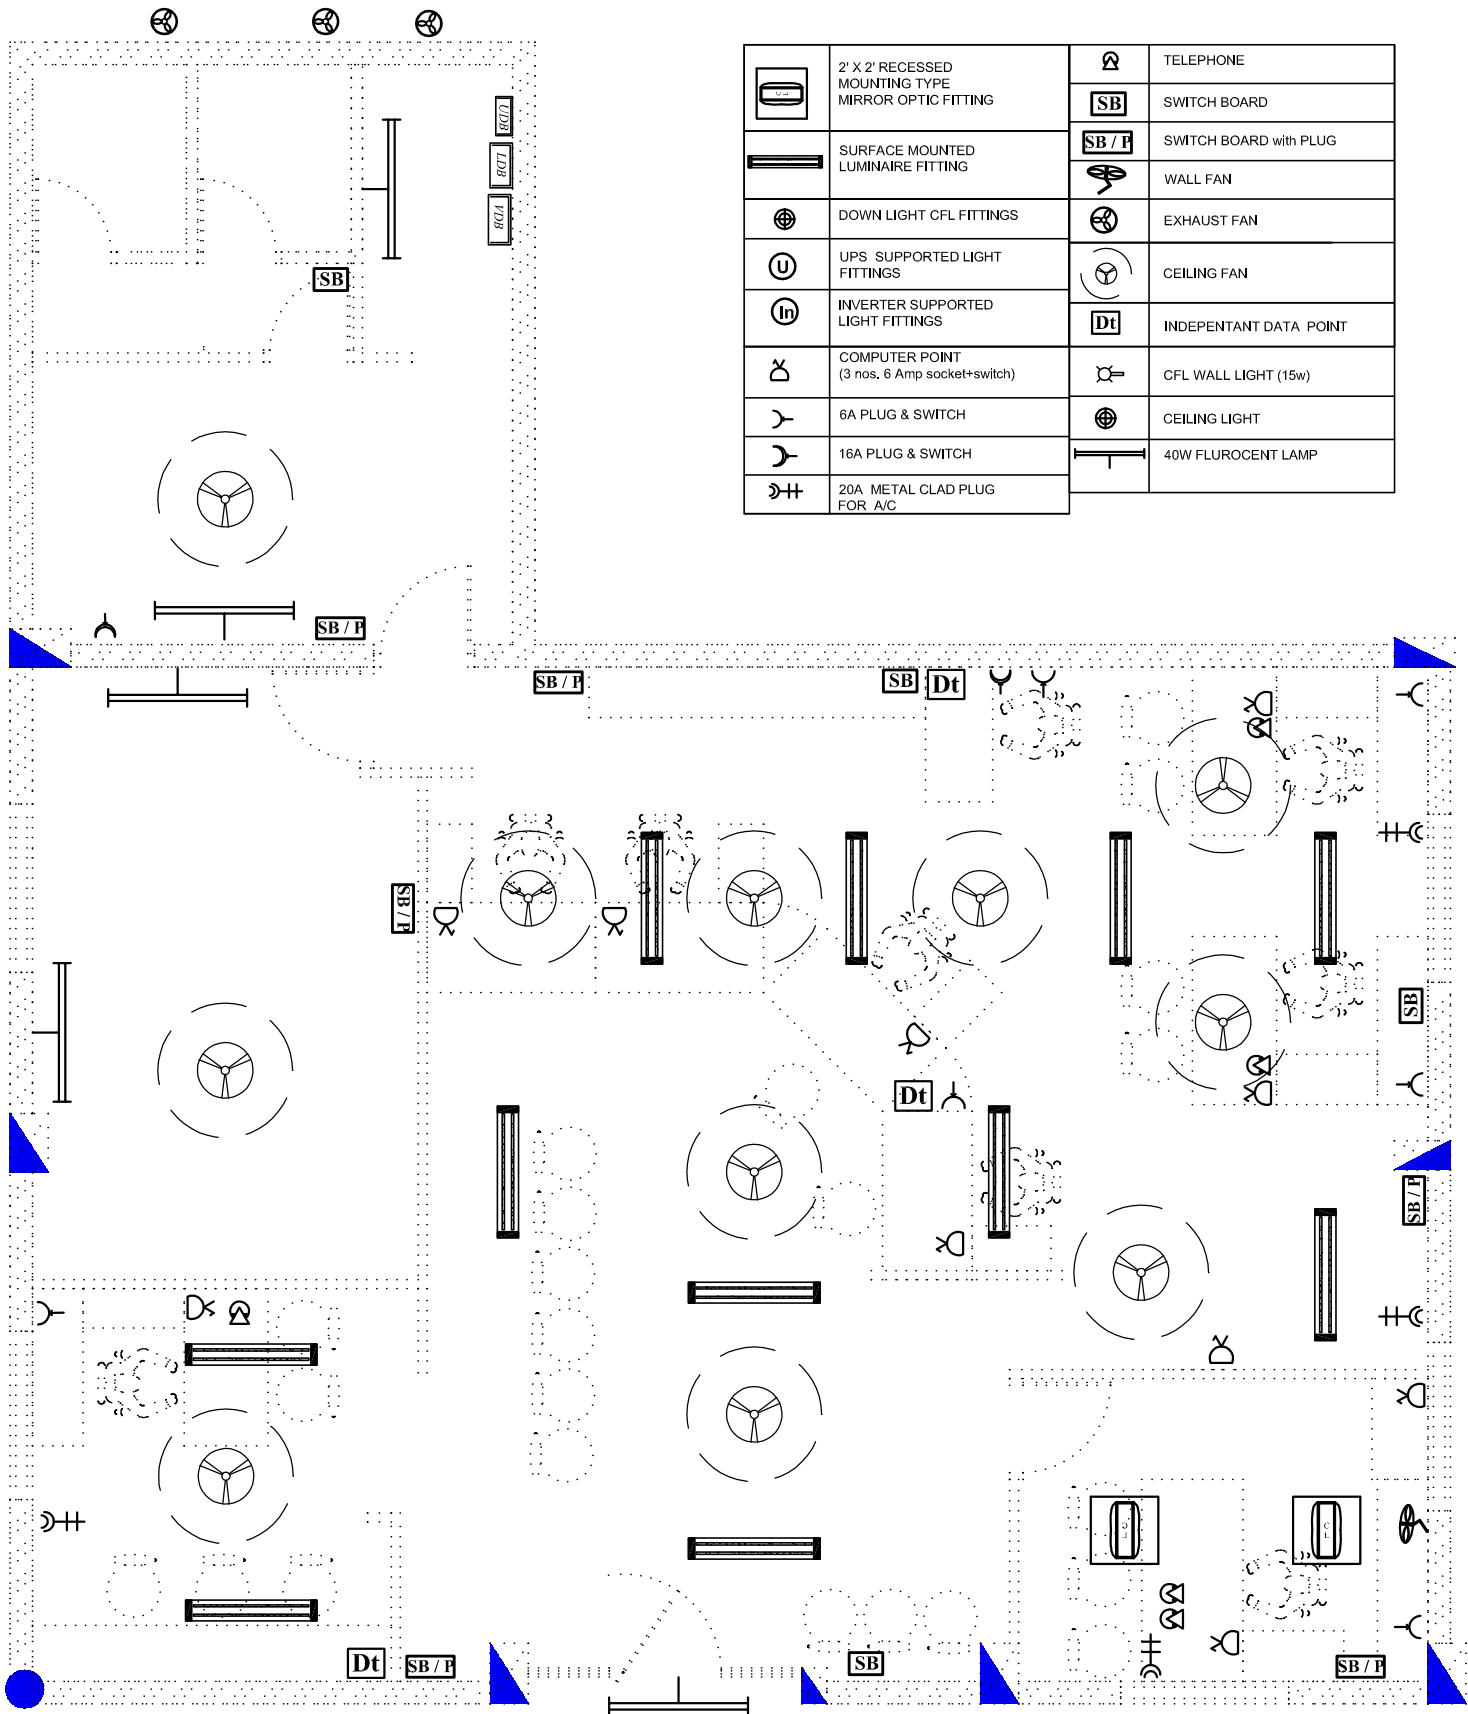

	2' X 2' RECESSED MOUNTING TYPE MIRROR OPTIC FITTING		TELEPHONE
	SURFACE MOUNTED LUMINAIRE FITTING		SWITCH BOARD
	DOWN LIGHT CFL FITTINGS		SWITCH BOARD with PLUG
	UPS SUPPORTED LIGHT FITTINGS		WALL FAN
	INVERTER SUPPORTED LIGHT FITTINGS		EXHAUST FAN
	COMPUTER POINT (3 nos. 6 Amp socket+switch)		CEILING FAN
	6A PLUG & SWITCH		INDEPENDANT DATA POINT
	16A PLUG & SWITCH		CFL WALL LIGHT (15w)
	20A METAL CLAD PLUG FOR A/C		CEILING LIGHT
			40W FLUROCENT LAMP

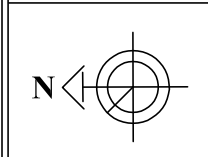

*Do not scale the drawing*

Date : 03-02-2017

Rev.Date : 10-03-2017

Drawing Title : Electrical Layout

Project : Pattambi Branch

Client : United India Insurance Company Limited


Option no : 2 Rev no : 2

Consultants :


**M** ANASARA CONSULTANTS

37/3744, Sreevalsam  
 Ponoth Road, Kaloor  
 Cochin-682017, Kerala  
 Ph: +91- 484 - 2102254  
 manasaradesigns@yahoo.com

All dimensions are in cm unless specified

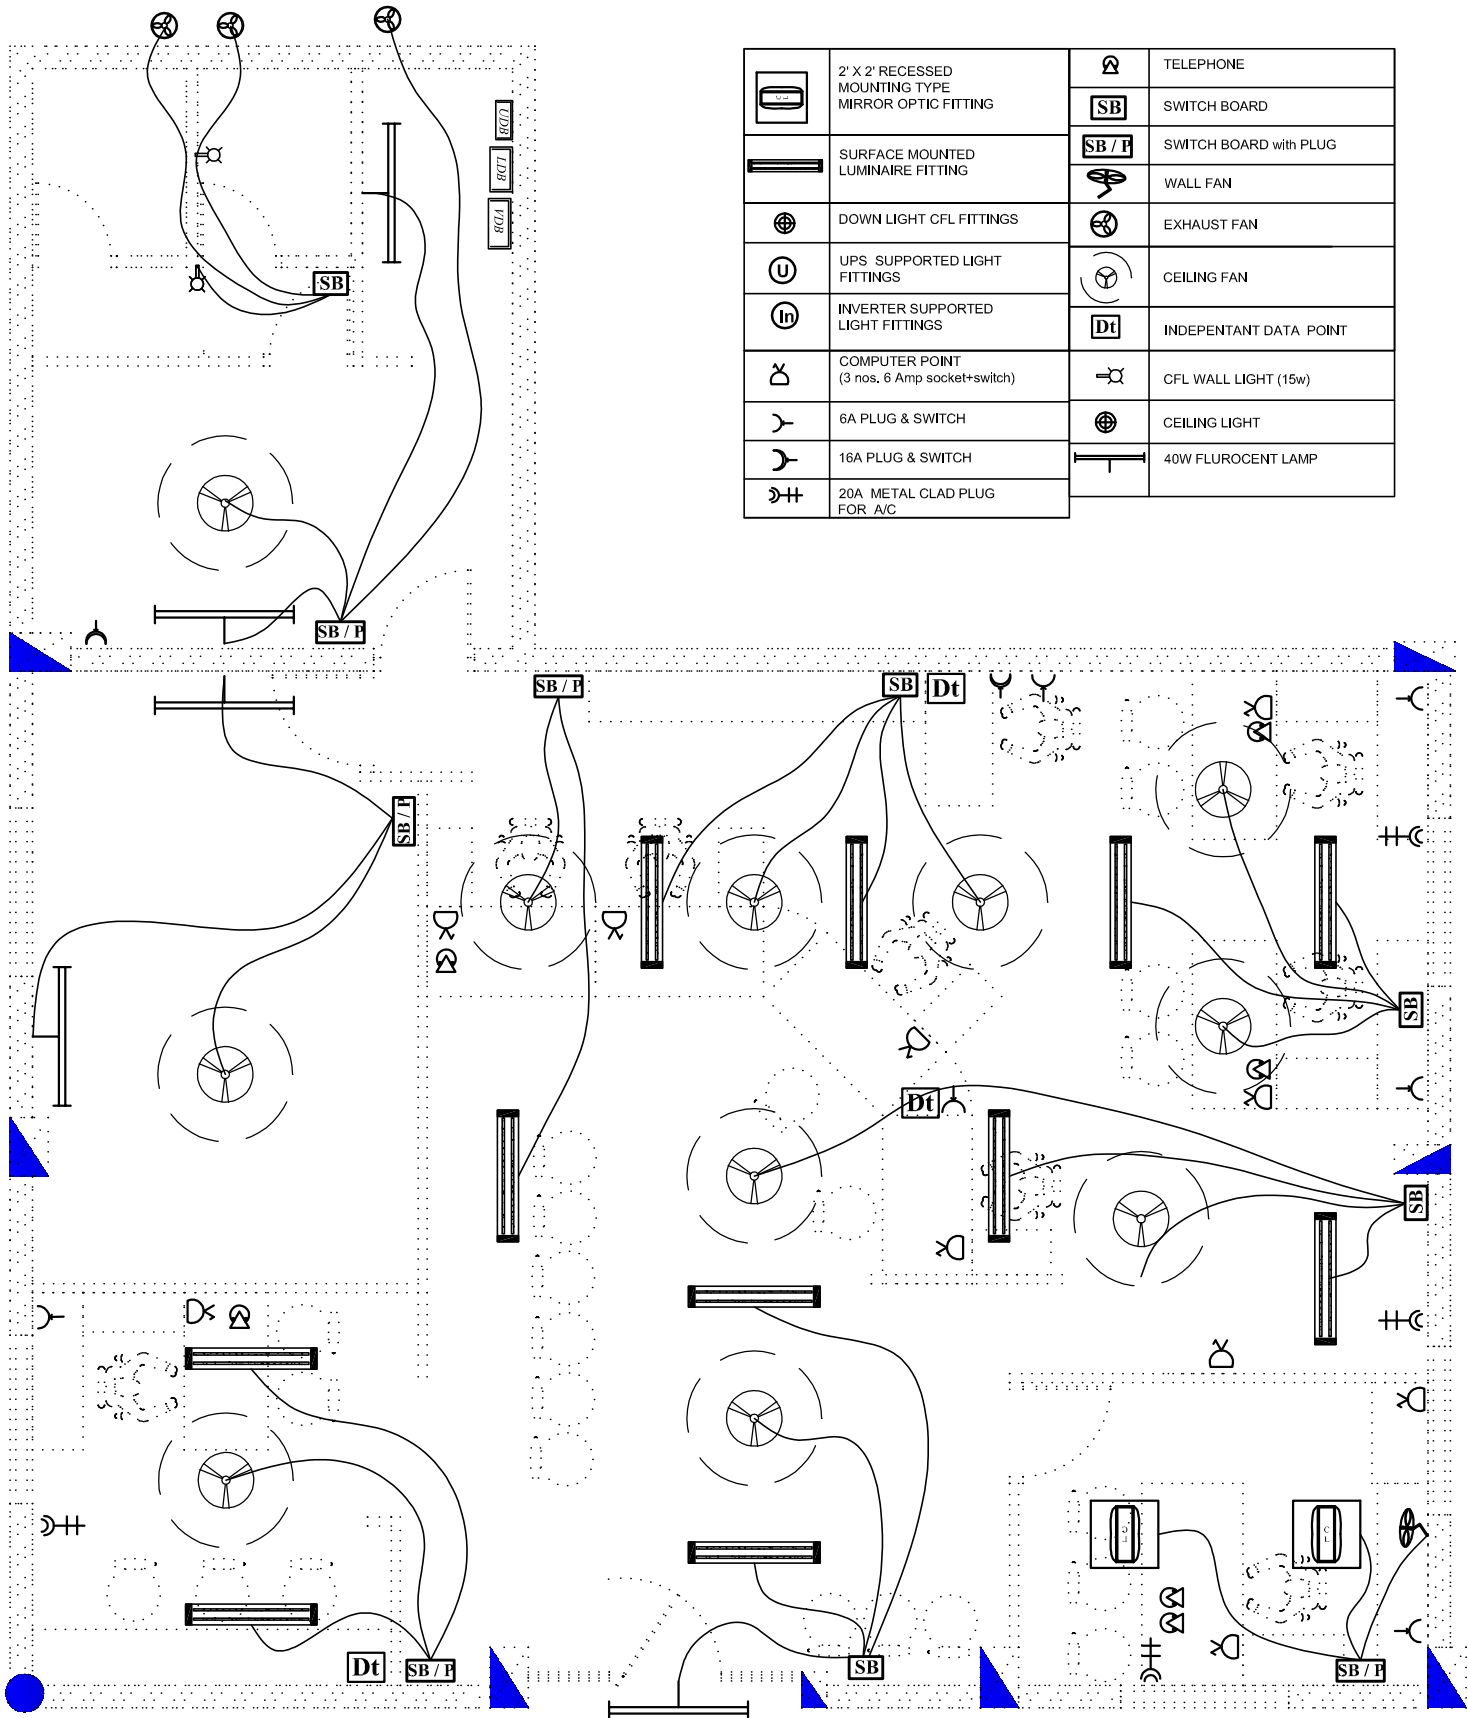

	2' X 2' RECESSED MOUNTING TYPE MIRROR OPTIC FITTING		TELEPHONE
	SURFACE MOUNTED LUMINAIRE FITTING		SWITCH BOARD
	DOWN LIGHT CFL FITTINGS		SWITCH BOARD with PLUG
	UPS SUPPORTED LIGHT FITTINGS		WALL FAN
	INVERTER SUPPORTED LIGHT FITTINGS		EXHAUST FAN
	COMPUTER POINT (3 nos. 6 Amp socket+switch)		CEILING FAN
	6A PLUG & SWITCH		INDEPENDANT DATA POINT
	16A PLUG & SWITCH		CFL WALL LIGHT (15w)
	20A METAL CLAD PLUG FOR A/C		CEILING LIGHT
			40W FLUROCENT LAMP

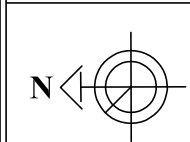

Do not scale the drawing

Date : 03-02-2017

Rev.Date : 10-03-2017

All dimensions are in cm unless specified

Drawing Title :

Wiring Layout

Project :

Pattambi Branch

Client : United India Insurance Company Limited

Option no : 2 Rev no : 2

Consultants :

**M**  
ANASARA CONSULTANTS  
37/3744, Sreevalsam  
Ponoth Road, Kaloor  
Cochin-682017, Kerala  
Ph: +91- 484 - 2102254  
manasaradesigns@yahoo.com