

Drawing not to scale

Drawing Title :

Interior Layout

Consultants :



Date : 25-09-2019

Project :

Amballoor Branch

Client :

United India Insurance Company Limited



ANASARA CONSULTANTS


Revised Date : 09-12-2019

Amballoor Branch

Option no : 03

All dimensions are in cm unless specified

373744, Sreeveeram  
Poruthi Road, Sector  
Cochin-682017, Kerala  
Ph: +91-484-210254  
manasaraesigns@yahoo.com

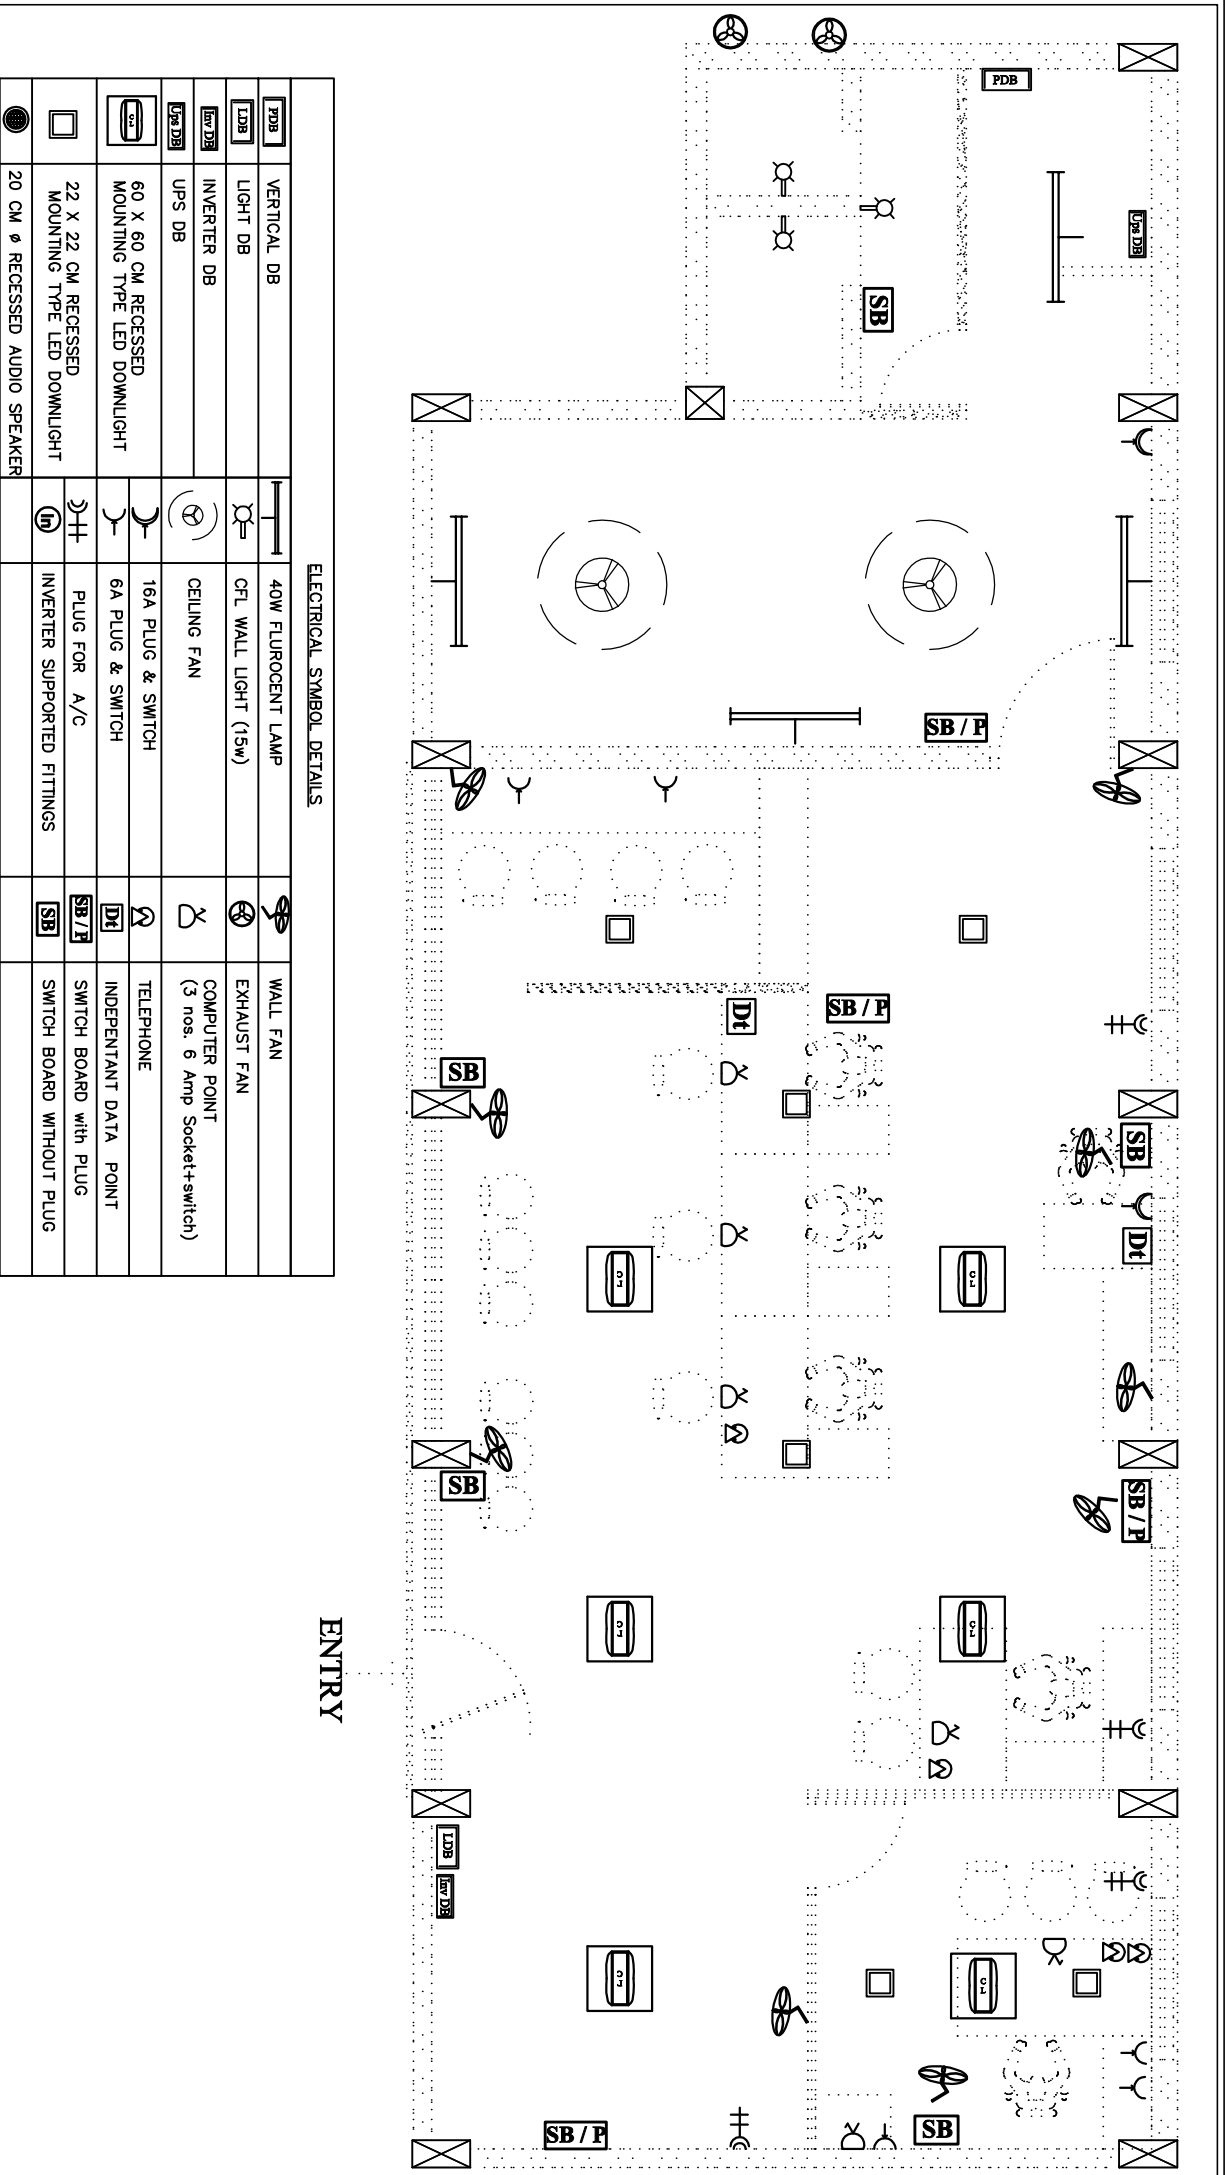

ELECTRICAL SYMBOL DETAILS

	VERTICAL DB		40W FLUROCENT LAMP		WALL FAN
	LIGHT DB		CFL WALL LIGHT (15w)		EXHAUST FAN
	INVERTER DB		CEILING FAN		COMPUTER POINT (3 nos. 6 Amp Socket+switch)
	UPS DB		16A PLUG & SWITCH		TELEPHONE
	60 X 60 CM RECESSED MOUNTING TYPE LED DOWNLIGHT		6A PLUG & SWITCH		INDEPENDANT DATA POINT
	22 X 22 CM RECESSED MOUNTING TYPE LED DOWNLIGHT		PLUG FOR A/C		SWITCH BOARD with PLUG
	20 CM Ø RECESSED AUDIO SPEAKER		INVERTER SUPPORTED FITTINGS		SWITCH BOARD WITHOUT PLUG

*Drawing not to scale*

*Drawing Title :*

**Electrical Layout**

*Consultants :*

Date : 25-09-2019

Project : **Amballoor Branch**

Client : **United India Insurance Company Limited**

Revised Date : 09-12-2019

Option no : 03

All dimensions are in cm unless specified

**M**  
ANASARA CONSULTANTS  
378744, Sreeveeram  
Poruthi Road, Amballoor  
Cochin-682017, Kerala  
Ph: +91-484-210254  
manasaraesigns@yahoo.com